


Notes:

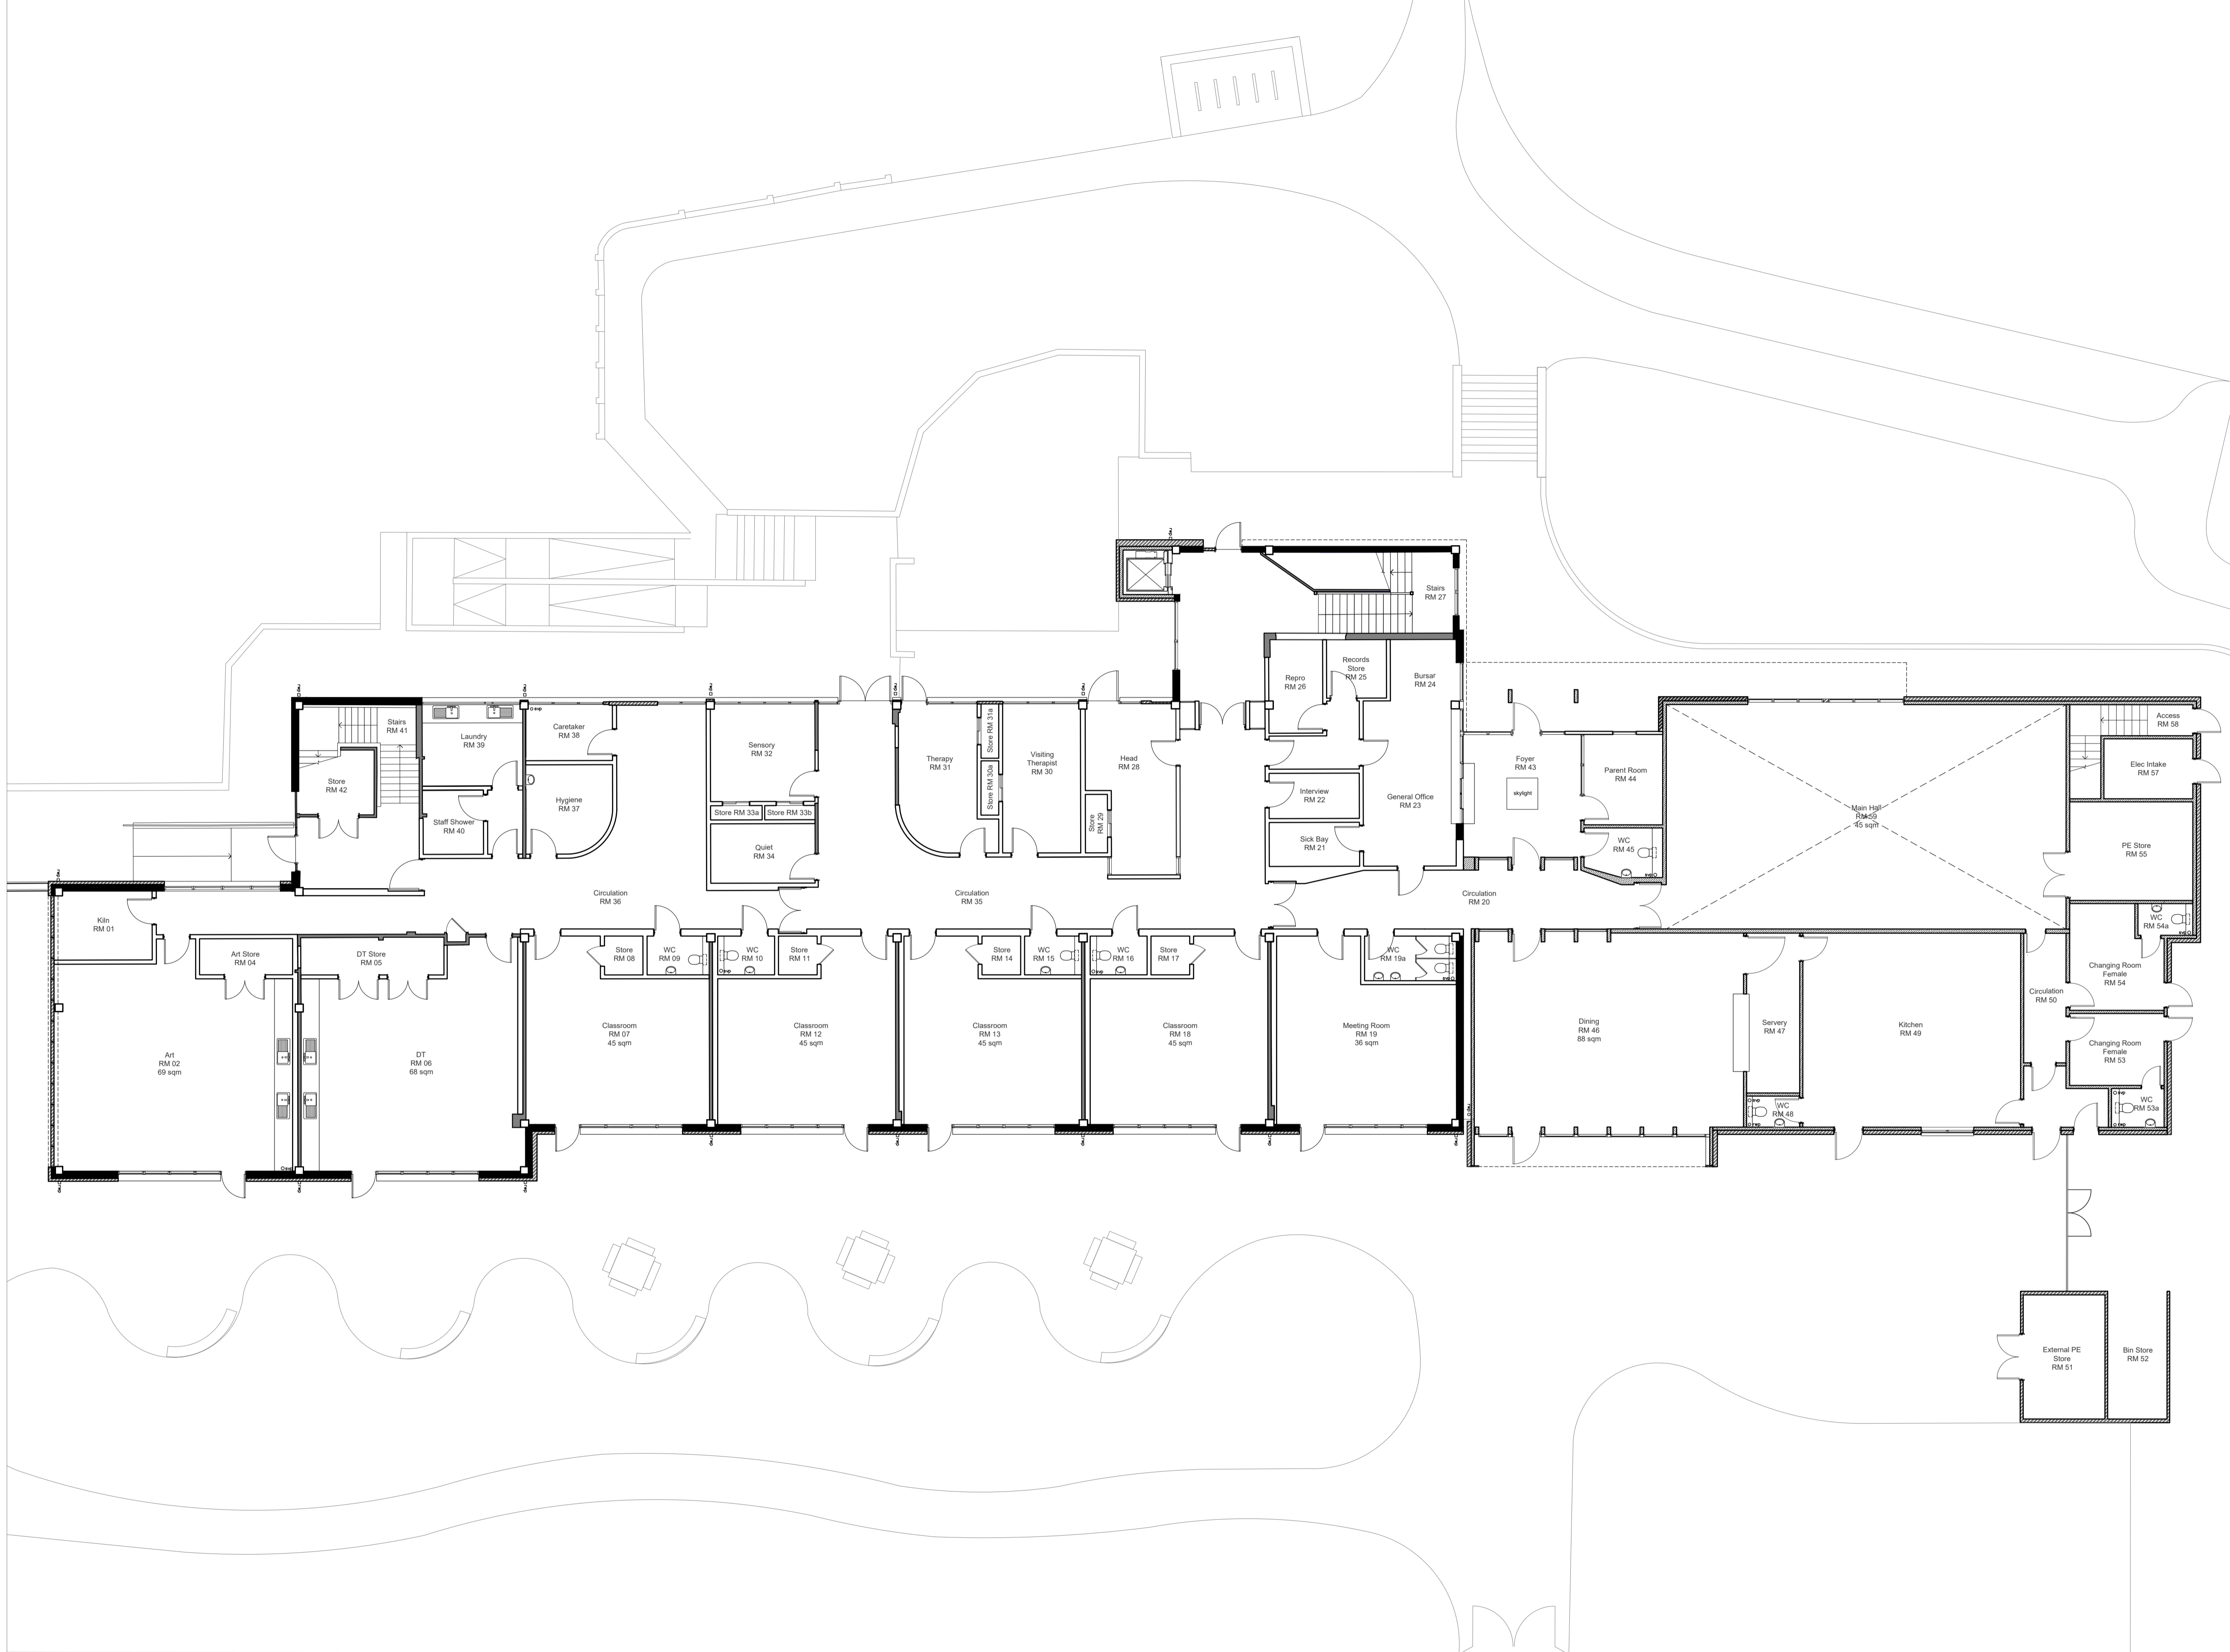

Rev	Description	Date	By	Chkd
P2	Planning consultation	29/08/2019	WN	MJC
P1	Information	23/07/2019	WN	MJC

HCC Property Services,  
The Castle,  
Winchester SO23 8UJ  
tel: (01962) 847801



PROJECT NAME  
**Hamilton Centre Conversion (Phoenix College)**

SHEET NAME  
**Proposed Ground Floor Plan**

SCALE  
NTS

DRAWN  
WN

CHKD  
MJC

APRV  
MJC

DRAWING No.  
project code - originator - volume - level - type - number version  
E03700-HCC-RF-00-DR-A-2000 P2